


SHEET NOTES:

- 1. ----- DENOTES INITIATION CIRCUIT
- 2. - - - - - DENOTES NOTIFICATION CIRCUIT

KEYED NOTES:

- ① PROVIDE HEAT DETECTOR(S) WITHIN 24" OF EACH SPRINKLER HEAD IN THE ELEVATOR CONTROL ROOM AND HOISTWAY (AS REQUIRED BY THE AHJ). HEAT DETECTORS SHALL HAVE A LOWER TEMPERATURE RATING THAN THE SPRINKLERS IN THE AREA AND BE MONITORED FOR INTEGRITY.
- ② SMOKE DETECTOR LOCATED IN 3RD LEVEL LOBBY.

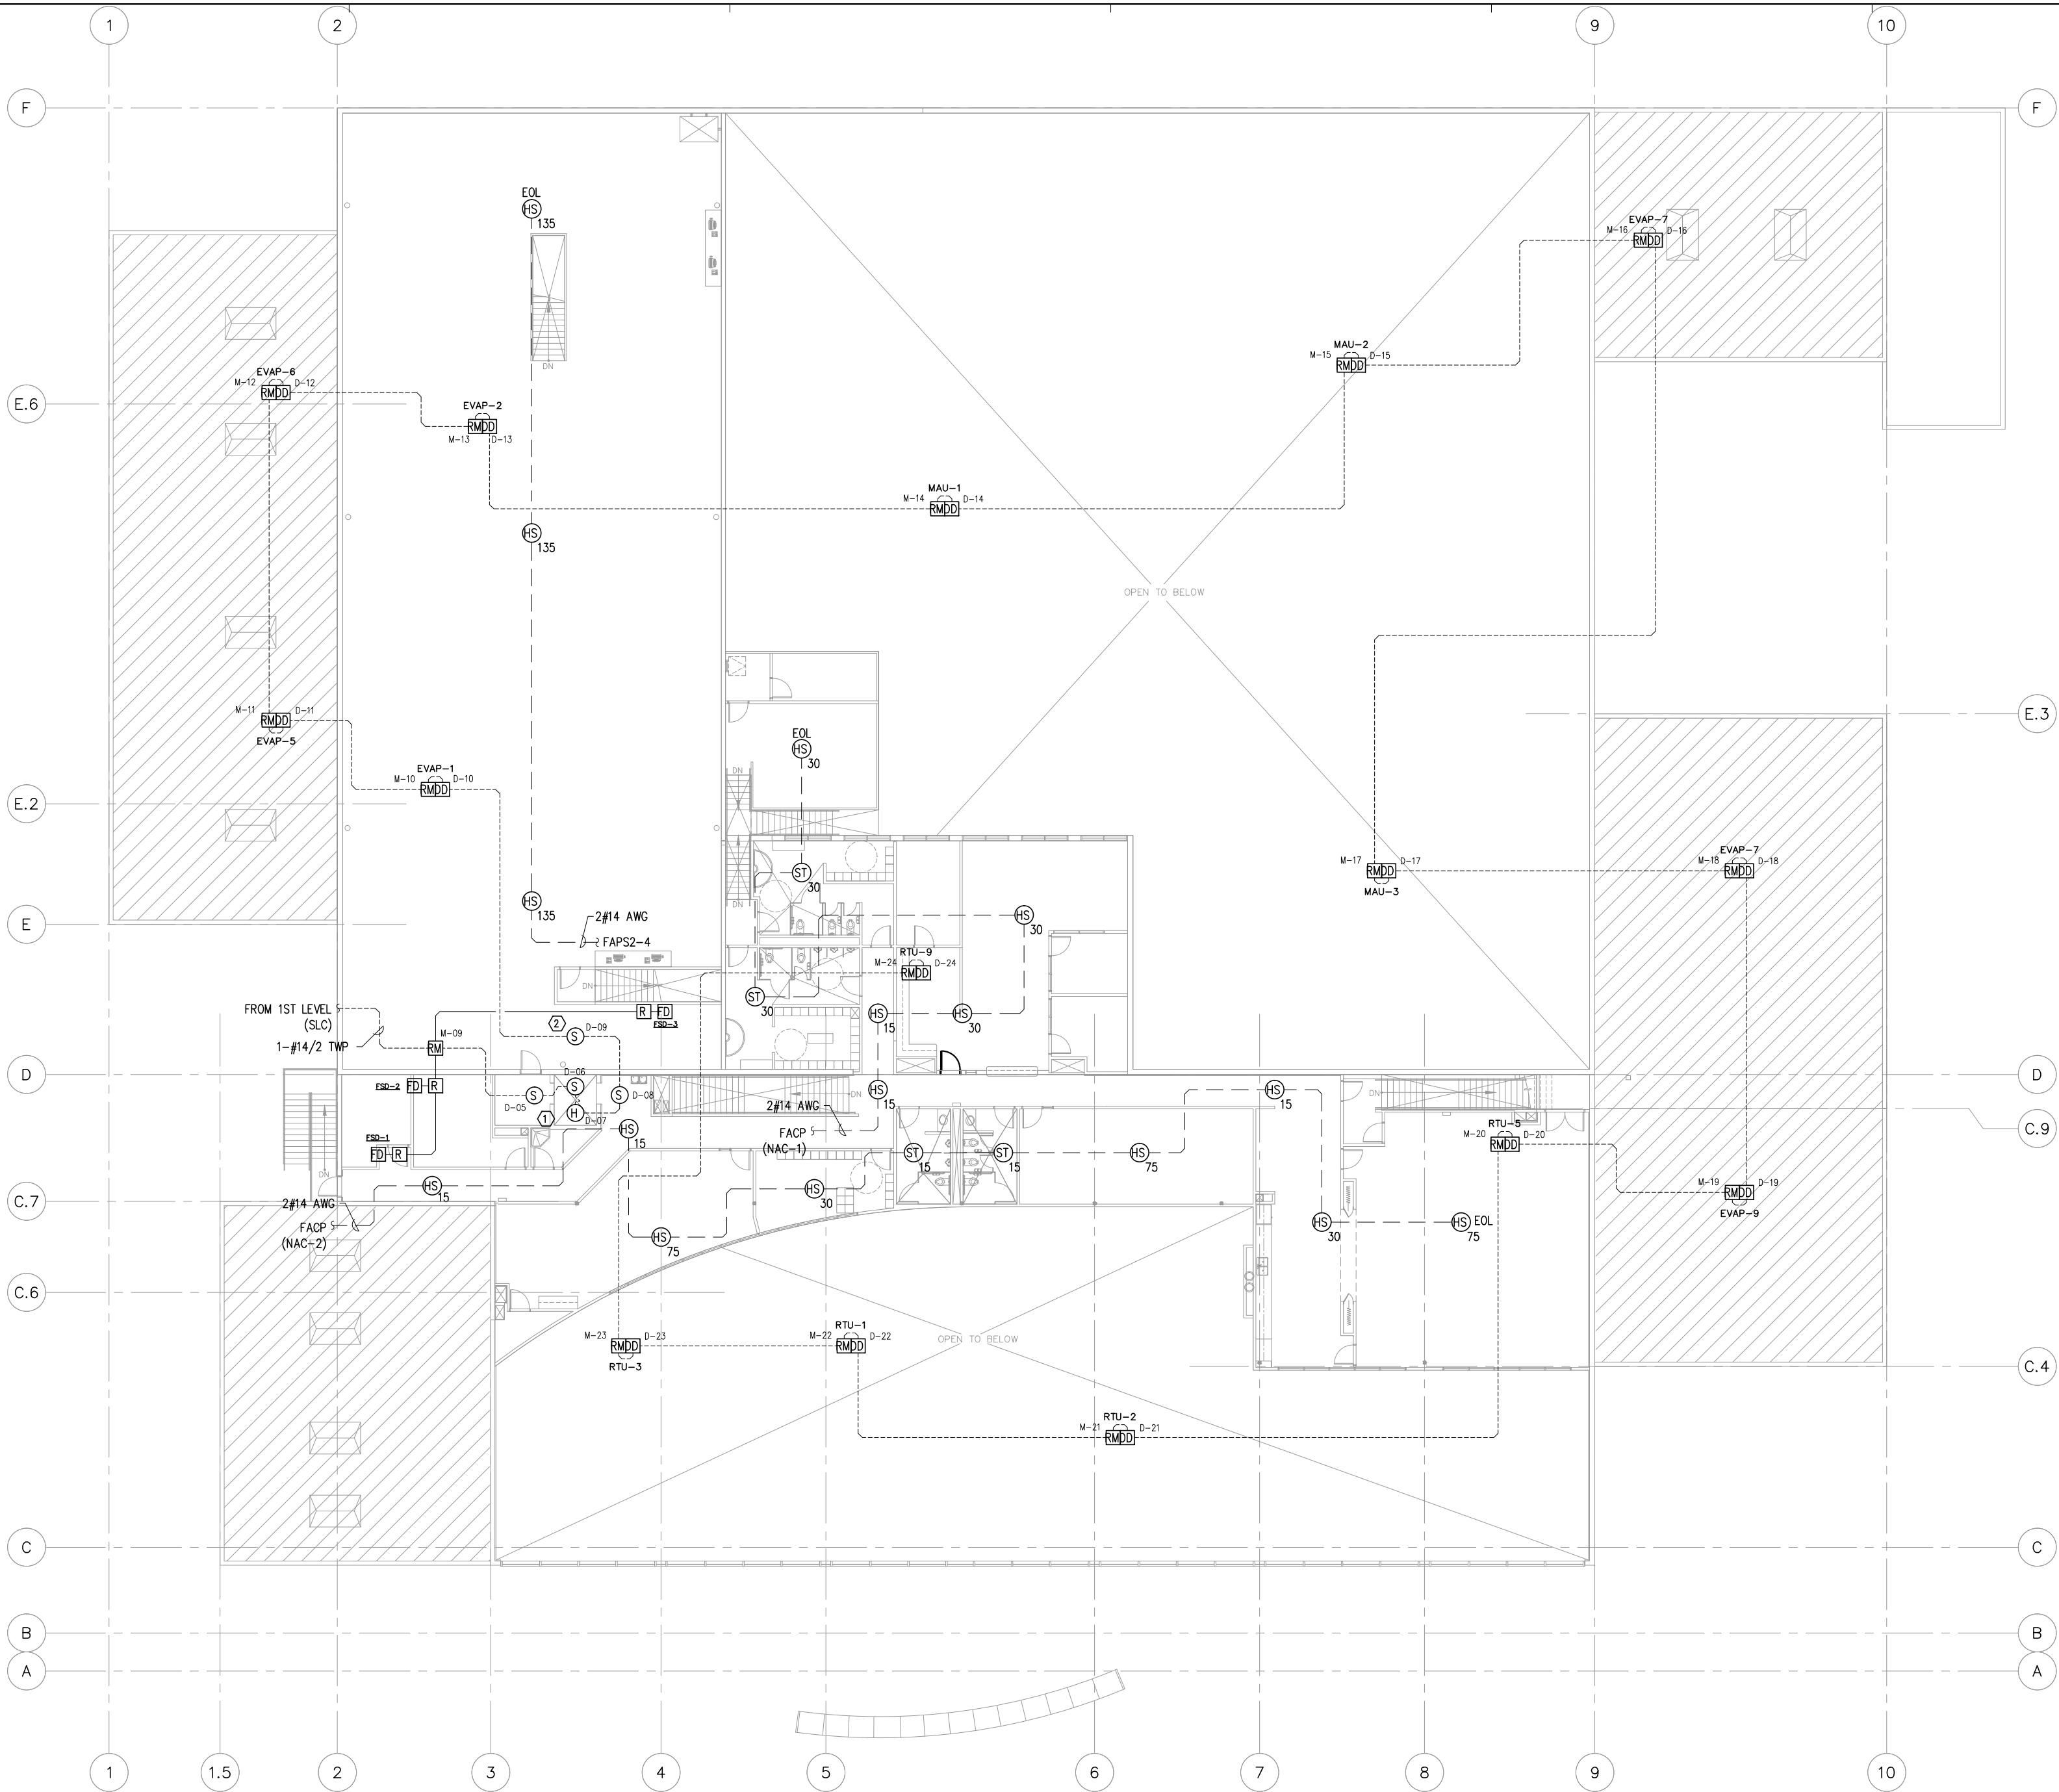

2ND LEVEL
SCALE: 3/32" = 1'-0"
FIRE ALARM PLAN

